
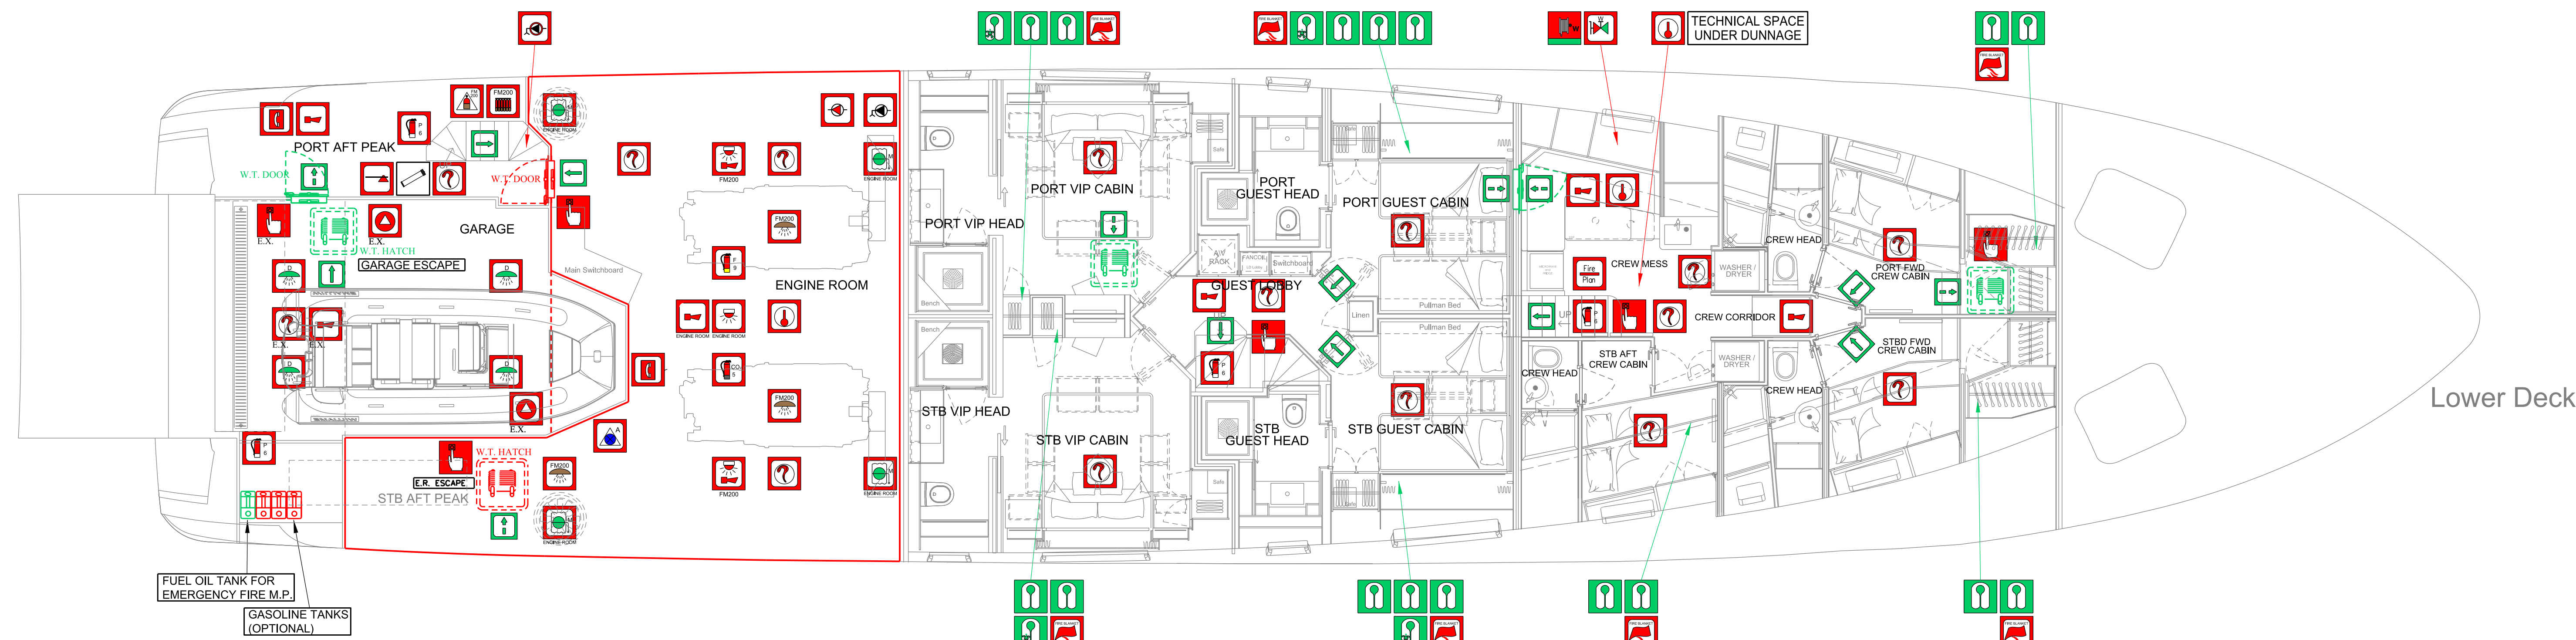
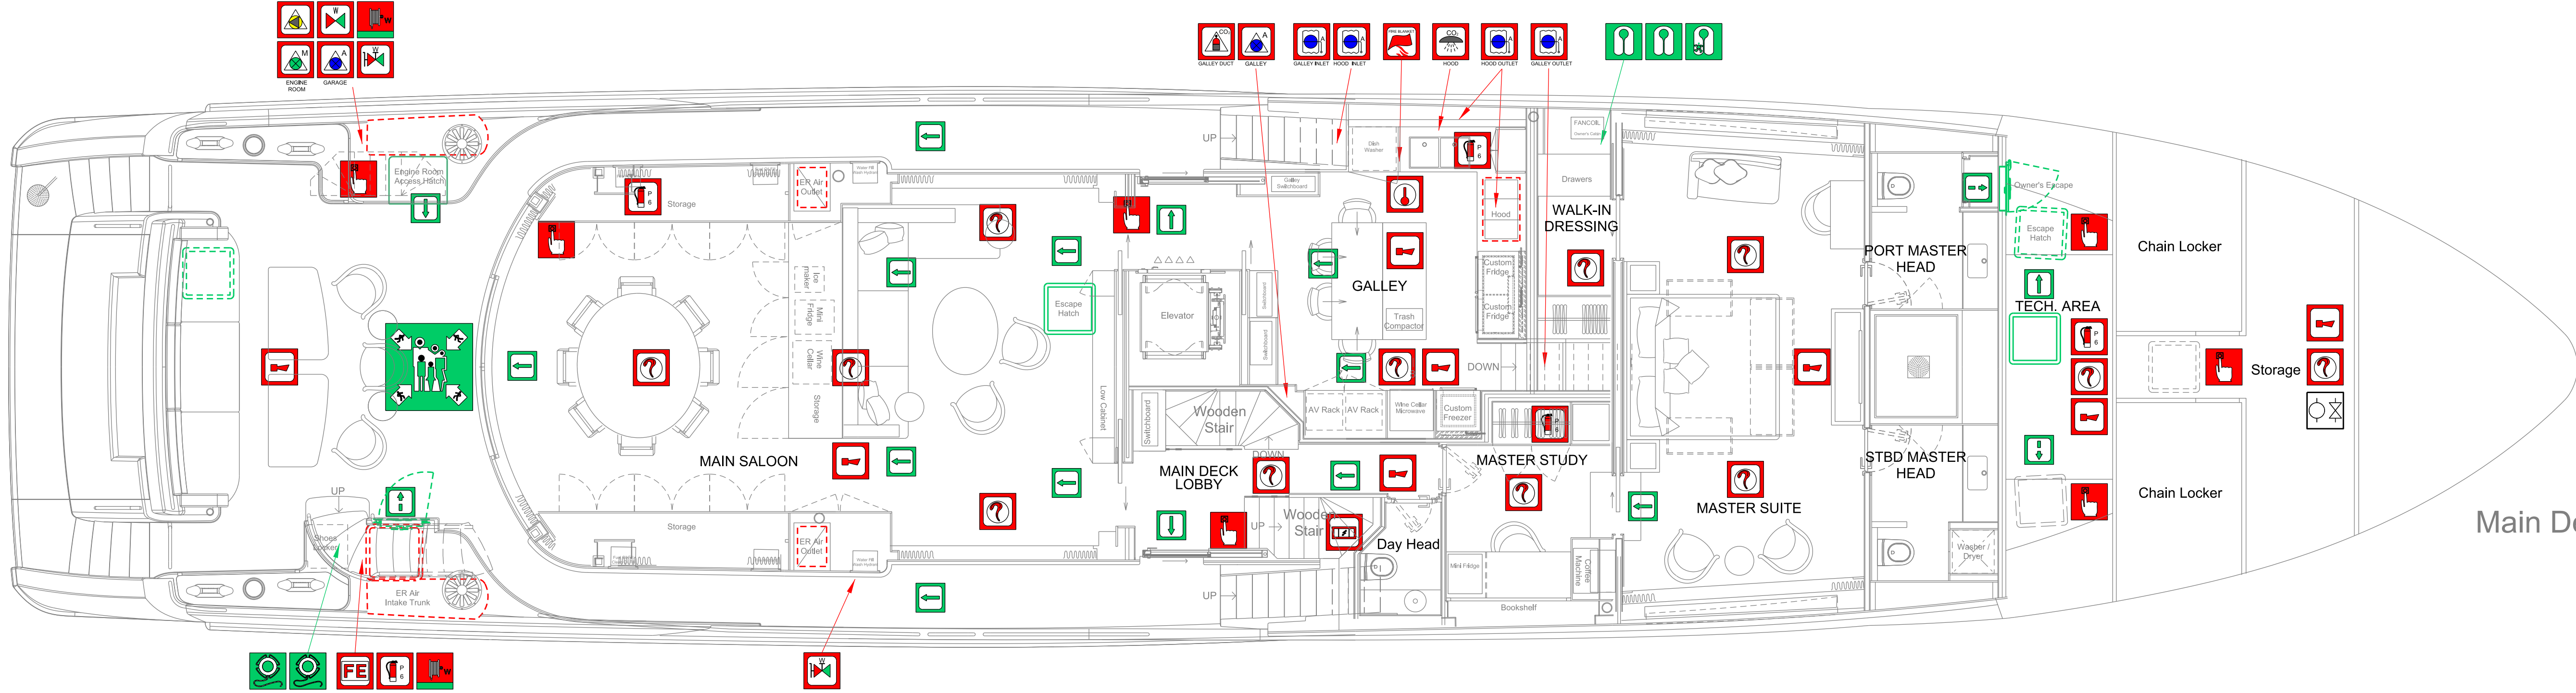
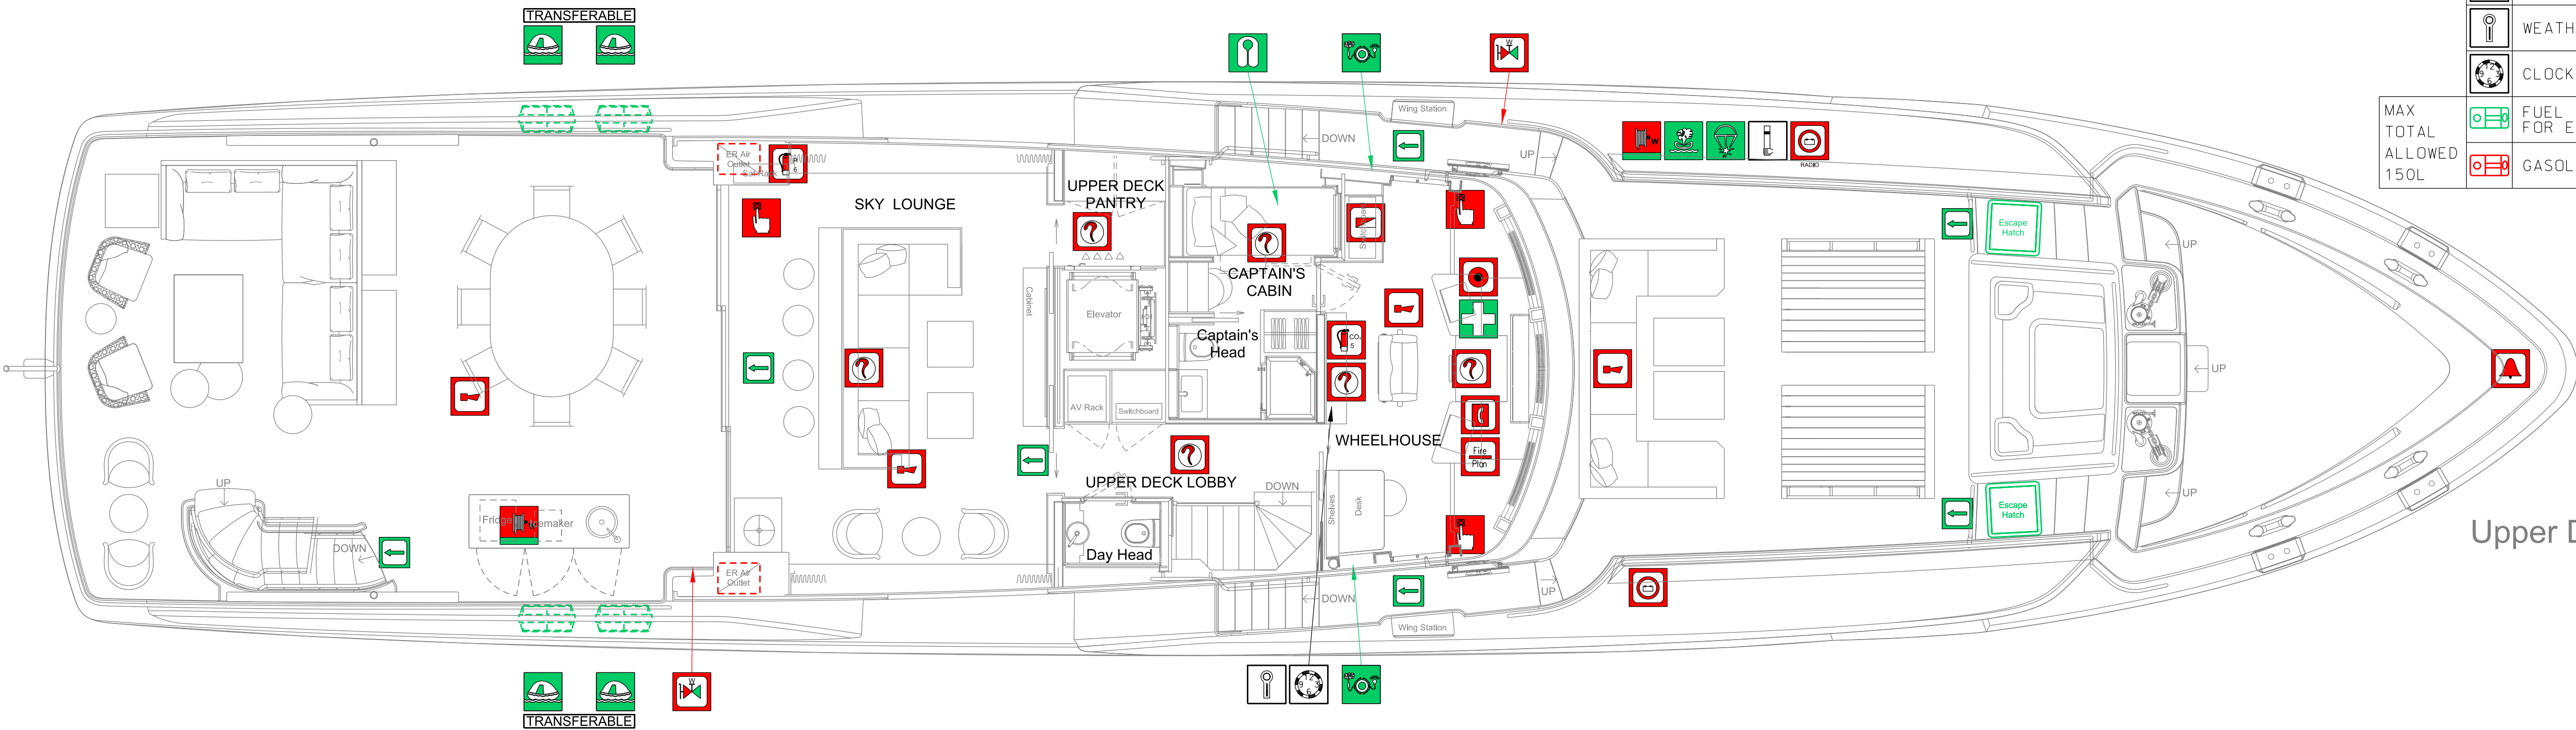


FIRE AND SAFETY PLAN

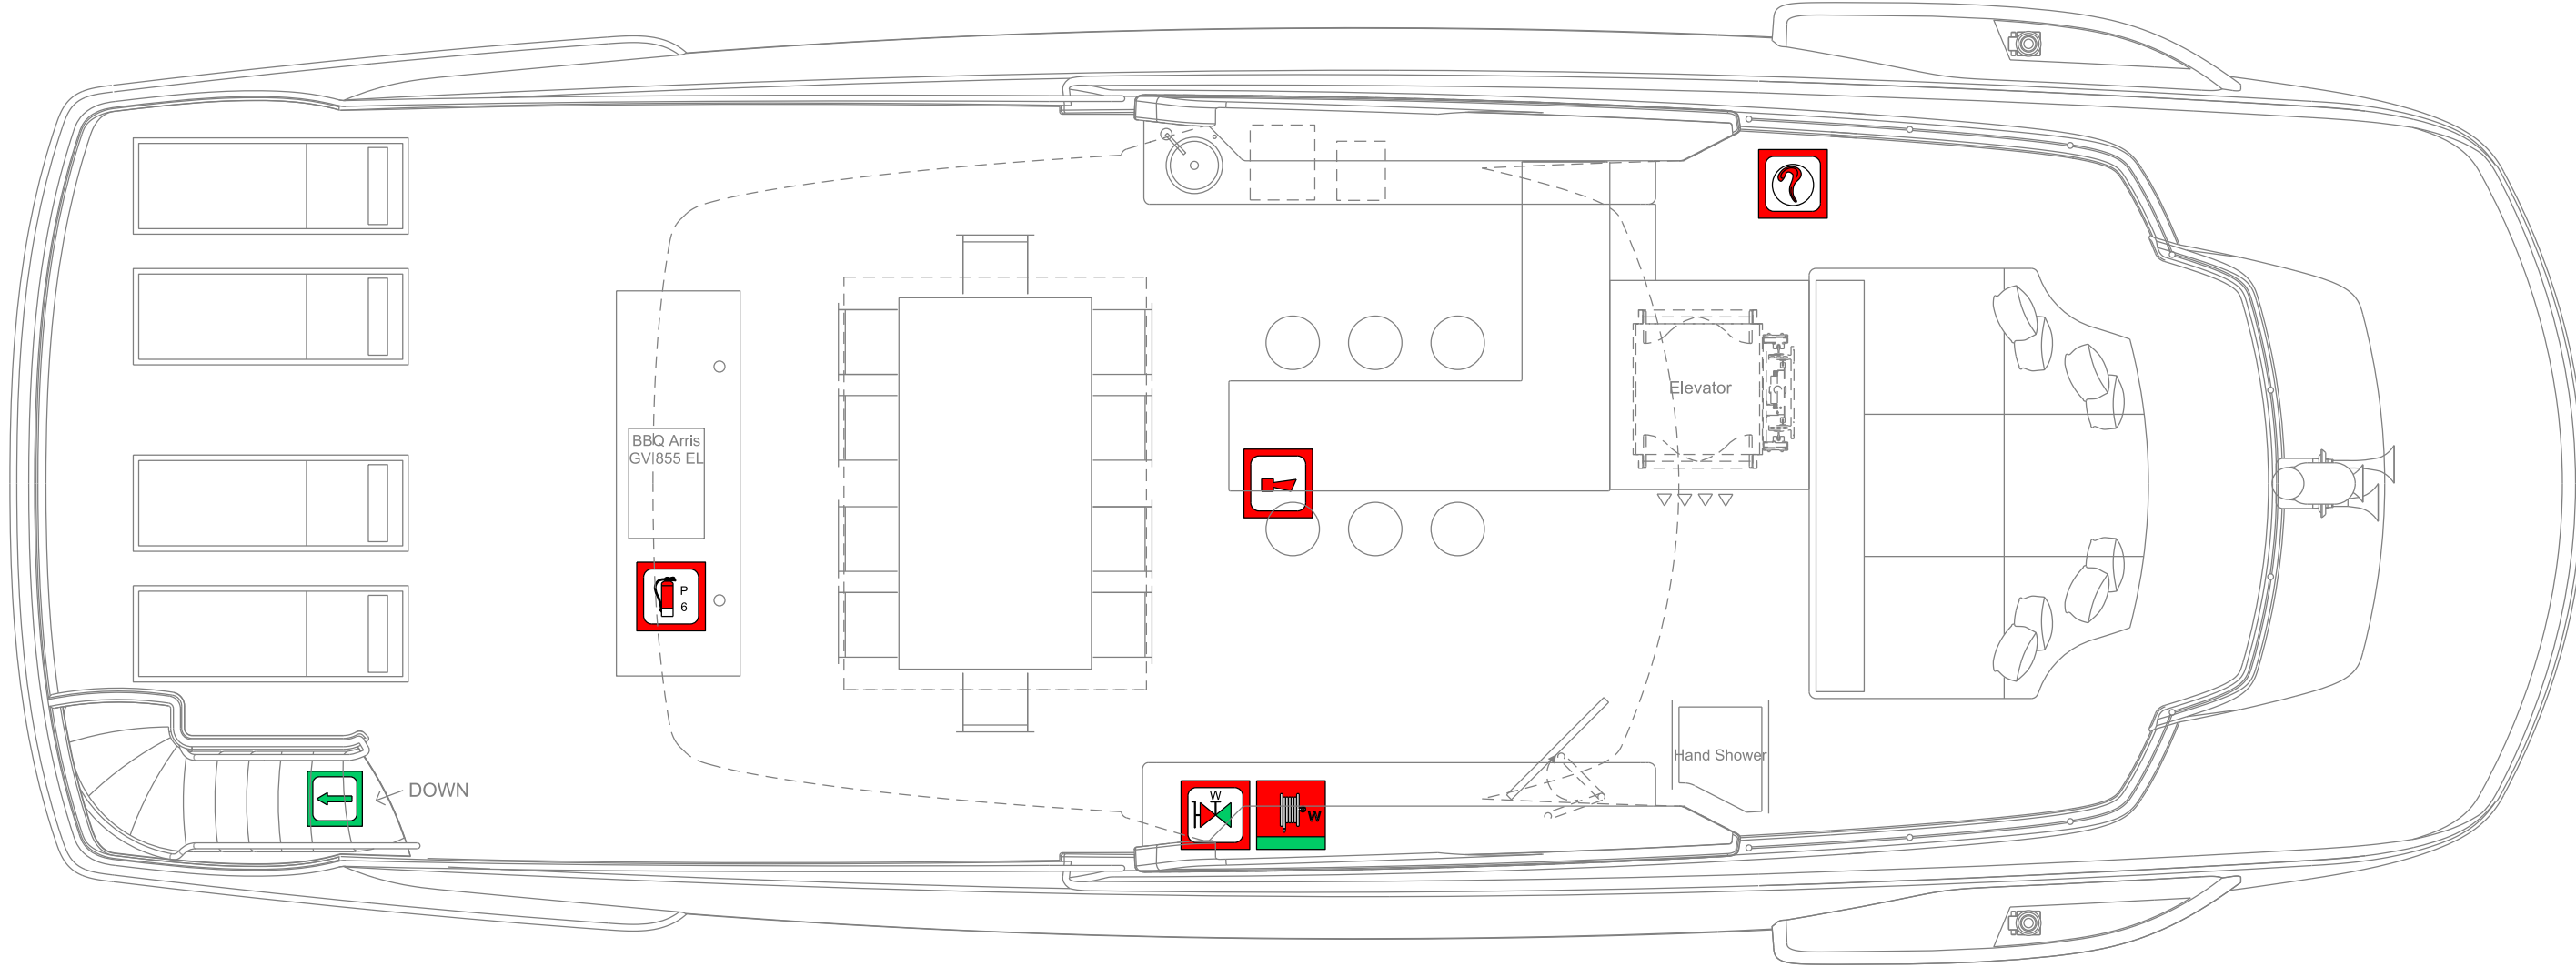

MUSTER STATION	1
FLOATING SMOKE SIGNAL (N. 2 Pz.)	1
PRIMARY ESCAPE ROUTE	-
SECONDARY MEANS OF ESCAPE	-
LIFERAFT - 6 PEOPLE, HYDROSTATIC RELEASE SOLAS A-PACK E.O. AND SOLAS APPROVED UNDER EC (MED)	4
LIFEBUOY WITH BUOYANT LINE (30m) SOLAS APPROVED UNDER EC (MED)	2
LIFEBUOY WITH LIGHT AND SMOKE SOLAS APPROVED UNDER EC (MED)	2
LIFEJACKET - WITH AUTOMATIC LIGHT AND WHISTLE SOLAS APPROVED UNDER EC (MED)	19
ROCKET PARACHUTE FLARES (N.6 Pz.)	1
MEDICAL KIT	1
CHILD'S LIFEJACKET - WITH AUTOMATIC LIGHT AND WHISTLE SOLAS APPROVED UNDER EC (MED)	5

SAFETY PLAN POSTER BOX	1
RED HAND FLARES (N. 6 Pz.)	1
NAVIGATION SHAPE SIGNALS (3 BALLS, 1 DIAMOND)	1
WEATHER STATION	1
CLOCK WITH SECTORS	1
FUEL OIL STOWAGE TANK (20L) FOR EMERGENCY FIRE/BILGE MOTOR PUMP	1
GASOLINE STOWAGE TANK (20L) - (OPTIONAL)	3

MAN. OPERATED CALL POINT	16
FIRE PROTECTION PLAN	2
FIRE MAIN ISOLATION VALVE	1
EMERGENCY BILGE PUMP - DIESEL DRIVEN FIRE/BILGE PUMP	1
FIRE PUMP	1
BILGE PUMP	1
FUEL OIL PUMPS REMOTE SHUT OFF	1
SPACE PROTECTED BY DRENCHING FIRE EXT. SYSTEM	4
CO2 REMOTE RELEASE STATION	1
CO2 FIXED FIRE EXT. BATTERY (GALLEY DUCT TOT.CHARGE=2kg)	1
SPACE PROTECTED BY CO2 FIRE EXT. SYSTEM	1
FM200 REMOTE RELEASE STATION	1
FM200 FIXED FIRE EXT. BATTERY (ENGINE ROOM TOT.CHARGE=60kg)	1
SPACE PROTECTED BY FM200 FIRE EXT. SYSTEM	3
FIRE DAMPER - MACHINERY	4
FIRE DAMPER - ACCOMMODATION AND SERVICE	4
VENTILATION REMOTE CONTROL SHUT-OFF (E.R.)	1
VENTILATION REMOTE CONTROL SHUT-OFF (GARAGE, GALLEY)	2
FIRE BLANKET	8
FIRE HOSE (15m) AND SPRAY/JET NOZZLE ND 12mm CONN. UNI45	6
SEA WATER FIRE HYDRANT, CONN. UNI45	5
SPACE MONITORED BY HEAT DETECTOR	4
SPACE MONITORED BY SMOKE DETECTOR	40
EMERGENCY TELEPHONE STATION - MAGNETOFONICO	3
SPACE MONITORED BY GAS DETECTOR	2
ACOUSTIC FIRE ALARM	21
OPTICAL FIRE ALARM	1
CONTROL PANEL FOR FIRE DETECTION AND ALARM SYSTEM	1
POWDER FIRE EXT. 6kg	10
CO2 FIRE EXT. 5kg	2
FOAM FIRE EXT. 9kg	1
OPTICAL AND ACOUSTIC ALARM (FM200)	1
SHIPS BELL	1
EMERGENCY SOURCE OF ELECTRICAL POWER (BATTERY)	2
EMERGENCY SWITCHBOARD	1
GENERAL ALARM WHISTLE AND SIREN	1
WATERTIGHT A CLASS FIRE DOOR	1
A CLASS DIVISION	-
LARGE FIREMAN AXE	1
FIREMAN'S OUTFITS - N.2 COMPRESSED AIR BREATHING APPARATUS - N.1 FIRE SUIT	1

00	12/04/2017	First Issue	L.Cabiddu
Rev./Upd.	Data/Date	Descrizione Modifica/Modity Description	Firma/Signature
Proprietà: R. AZIMUT-BENETTI S.p.A. Disegnato e approvato: L. Cabiddu Approvato: L. Cabiddu Il presente disegno non potrà essere utilizzato per la costruzione dell'apparato appartenente né venire copiato o ristampato senza permesso. La società proprietaria non è responsabile di errori o omissioni.			A0
Scale: 1:50			Nome: L.Cabiddu
FIRE AND SAFETY PLAN			Disegnato/Disegnata: L.Cabiddu
PIANO SICUREZZA E ANTINCENDIO			Disegnato/Disegnata: L.Cabiddu
Accommodations for: OWNER.....02 PRS. GUEST.....10 PRS. CREW.....07 PRS.			Disegnato/Disegnata: L.Cabiddu
Completamento/Completion: BM002	Disegnato/Disegnata: 2905	Scala/Scale: 1/1	Data/Date: 12/04/2017